

All ideas, designs, arrangement and plans indicated or represented by this drawing are the property of Panda Express Inc. and were created for use on this specific project. None of these ideas, designs, arrangements or plans may be used by or disclosed to any person, firm, or corporation without the written permission of Panda Express Inc.

REVISIONS:

[illegible]

ISSUE DATE:

PEER REVIEW	01-27-20
PR RESPONSE 1	02-21-20
BUILDING PERMIT	03-11-20

DRAWN BY: CSW


PANDA PROJECT #: D7446
ARCH PROJECT #: JCPT19-0314

NORR
ARCHITECTS ENGINEERS PLANNERS

PANDA EXPRESS
GREENBRIAR TOWN CENTER,
13059 LEE JACKSON MEMORIAL HWY
FAIRFAX, VA 22033


A-102

ROUGH - IN PLUMBING PLAN

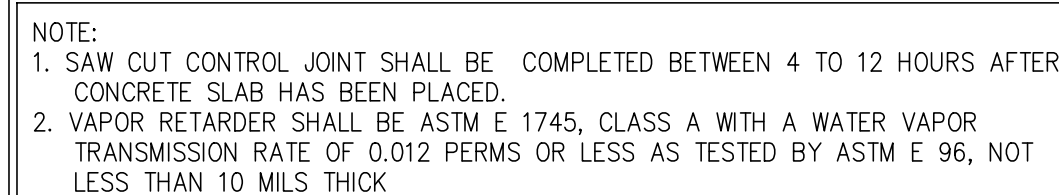


TYPICAL JOINT DETAIL	3
----------------------	---

Scale= NO SCALE	A-102
-----------------	-------

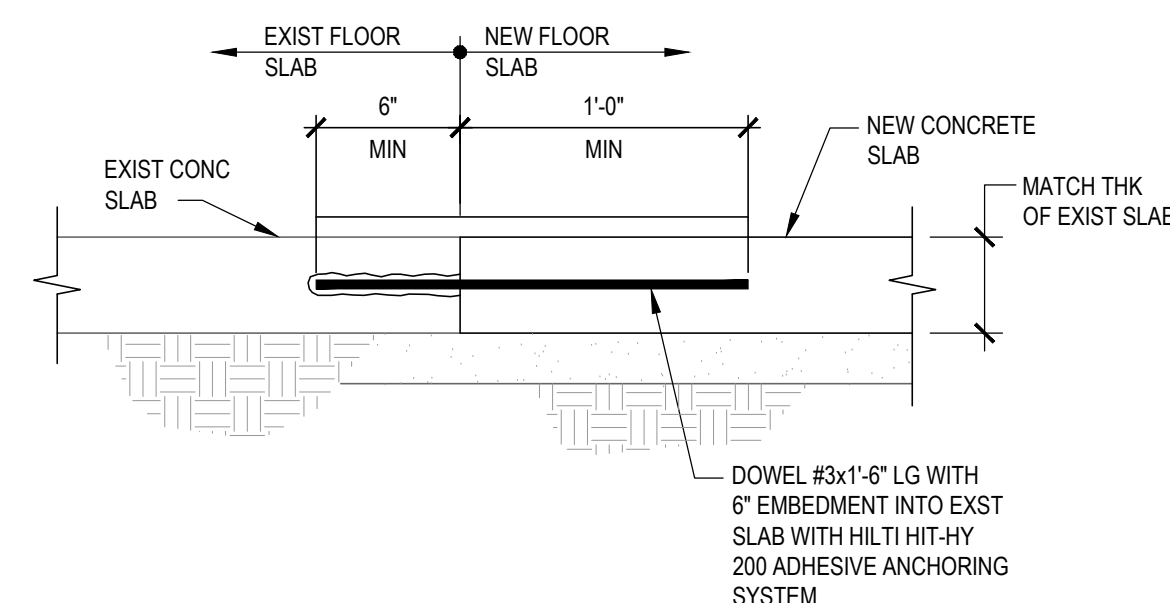

TYPICAL TIE-IN TO EXISTING SLAB 2

Scale= 1 1/2" = 1'-0"	A-102
-----------------------	-------

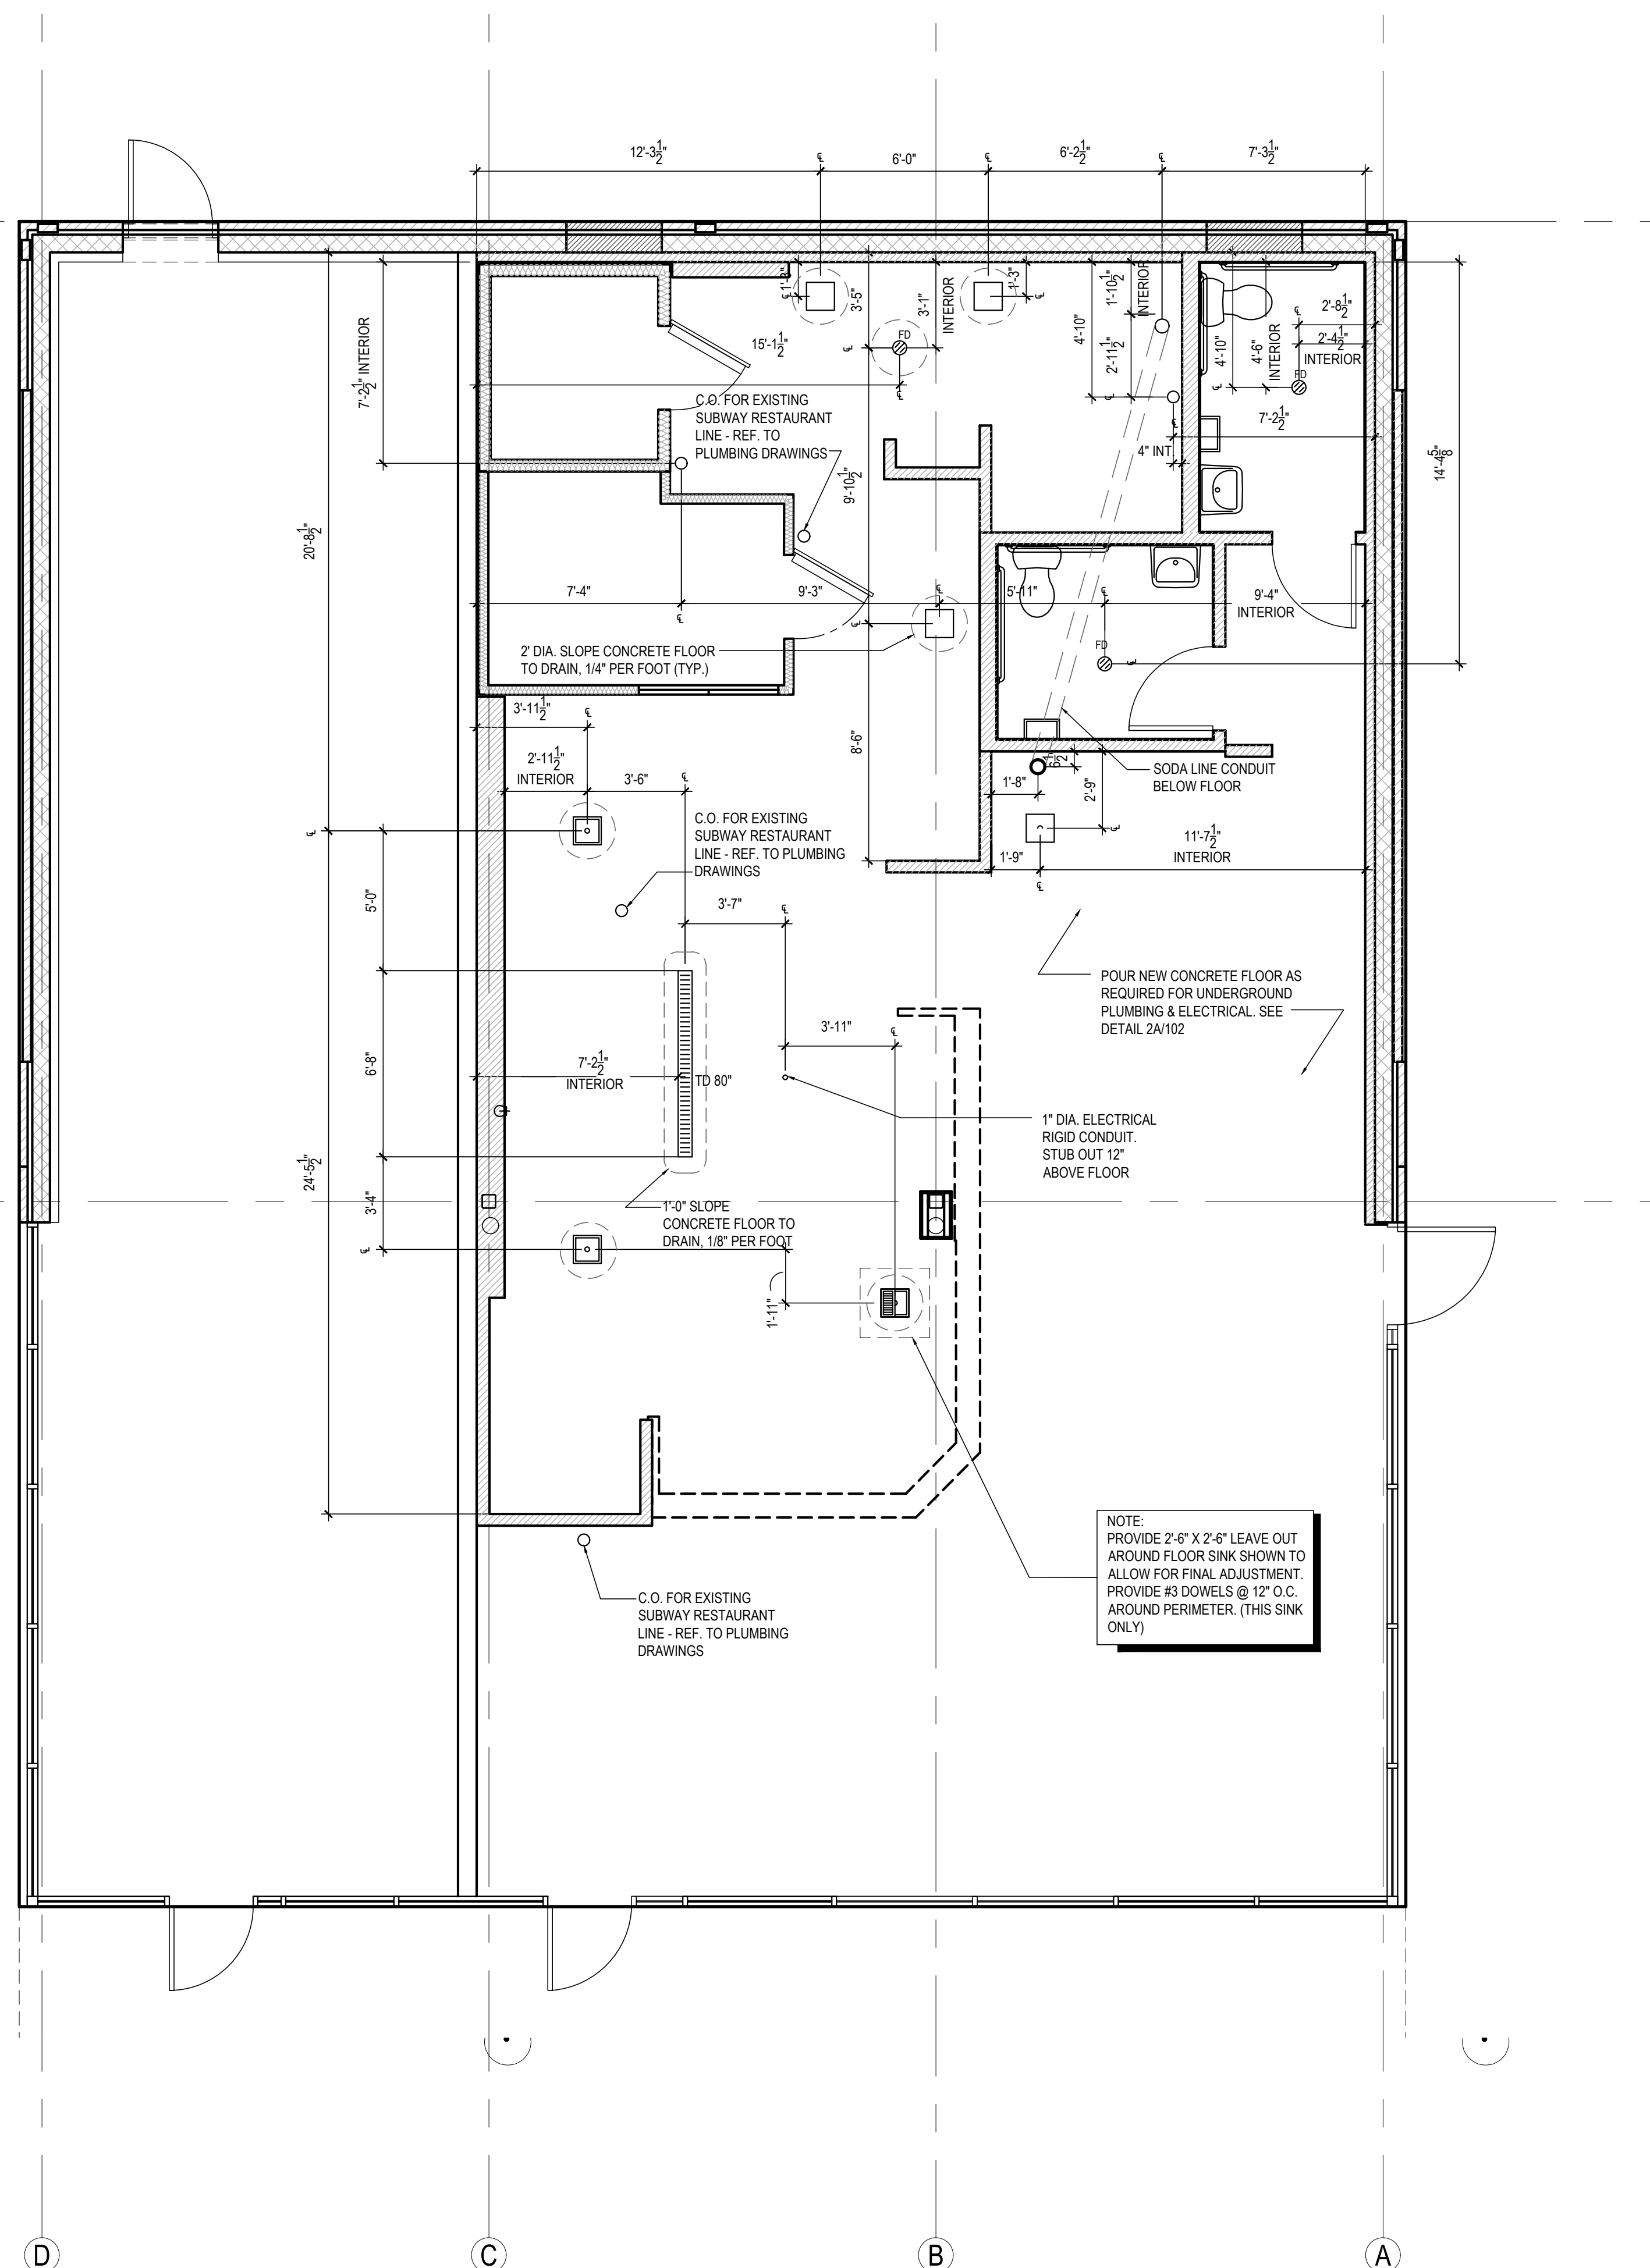

ROUGH - IN PLUMBING PLAN	1
--------------------------	---

Scale= 1/4" = 1'-0" A-10

